

UTILITY OWNERS

CON COMMUNICATIONS
 KIM BROWN
 SR ACCOUNT EXECUTIVE
 Kim.Brown@Con.com
 (757)-361-4376

VERIZON
 BLANQUART, PIERRE E
 pierre.blanquart@verizon.com
 (757)-845-5283


 
 

DOMINION ENERGY
 JOE PINCUS
 902 G STREET
 HARRISON, VIRGINIA 23161
 Joseph.pincus@dominionenergy.com
 (757)-262-9107

KEVIN O STARKE
 VIRGINIA NATURAL GAS
 544 S INDEPENDENCE BLVD
 VIRGINIA BEACH, VA 23452
 kstarke@vng.com
 (757)-616-7529


ROBERT E COSBY
 NEWPORT NEWS WATERWORKS
 720 TOMM CENTER DRIVE, SUITE 400
 NEWPORT NEWS, VA 23606
 rcosby@nww.com
 (757)-926-1101

DION WALSH
 JAMES CITY SERVICE AUTHORITY
 119 TOWNING ROAD
 WILMINGSBURG, VA 23188
 (757)-253-6800

- NOTE:**
- CONTRACTOR TO FIELD VERIFY ALL EXISTING UTILITY DEPTHS AND CROSSINGS FOR ANY POTENTIAL CONFLICTS
 - ALL STORM PIPES TO BE 3" COUNTER SUNK
 - REFER TO SHEET C73 FOR STORM PROFILE OF STRUCTURE 44 TO 47

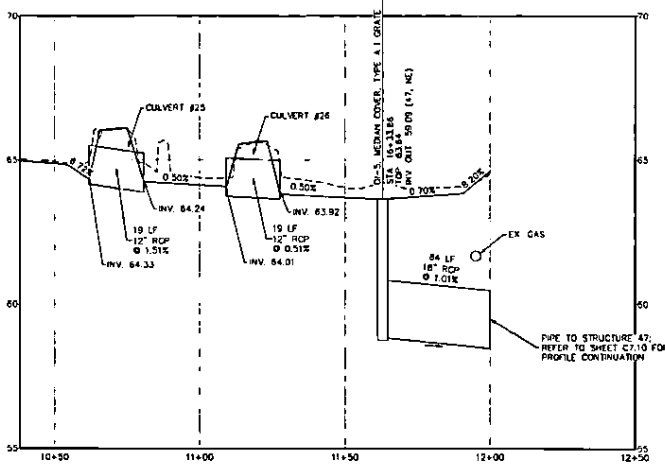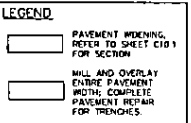

JACKSON STREET WEST STA. 4+80' - 10+25' - Scale: H: 1"=20', V: 10.00:1

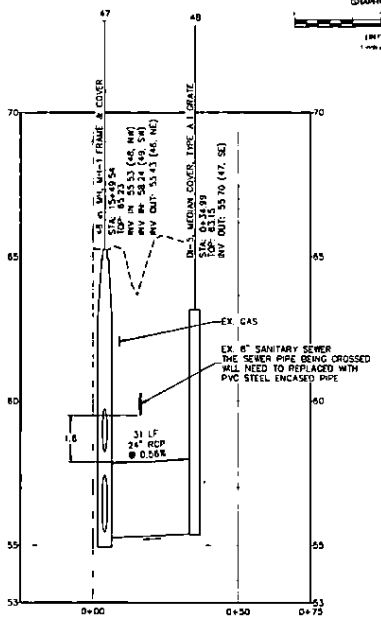

STORM PROFILE 47-48 - Scale: H: 1"=20', V: 10.00:1



Draper Aden Associates
 Engineering • Surveying • Environmental Services
 1033 Wilshire Avenue, Suite 103
 Richmond, VA 23227
 804-362-2221 Fax: 804-362-2222
 www.draperaden.com

• Lynchburg, VA
 • Charlottesville, VA
 • Christiansburg, VA
 • Harrisonburg, VA
 • Williamsburg, VA

SITE LAYOUT & GRADING PLAN & PROFILE - JACKSON ST WEST GROVE AREA STORMWATER DRAINAGE & RELATED ROADWAY IMPROVEMENTS
 JAMES CITY COUNTY, VIRGINIA

REVISIONS

| NO. | DATE | DESCRIPTION |
|-----|------|-------------|
| | | |

| | |
|----------------|------------------|
| DESIGNED BY | ALB |
| DRAWN BY | KMD |
| CHECKED BY | GHC |
| SCALE | 1" = 20' |
| DATE | OCTOBER 04, 2023 |
| PROJECT NUMBER | B18108B-05 |

C7.3